


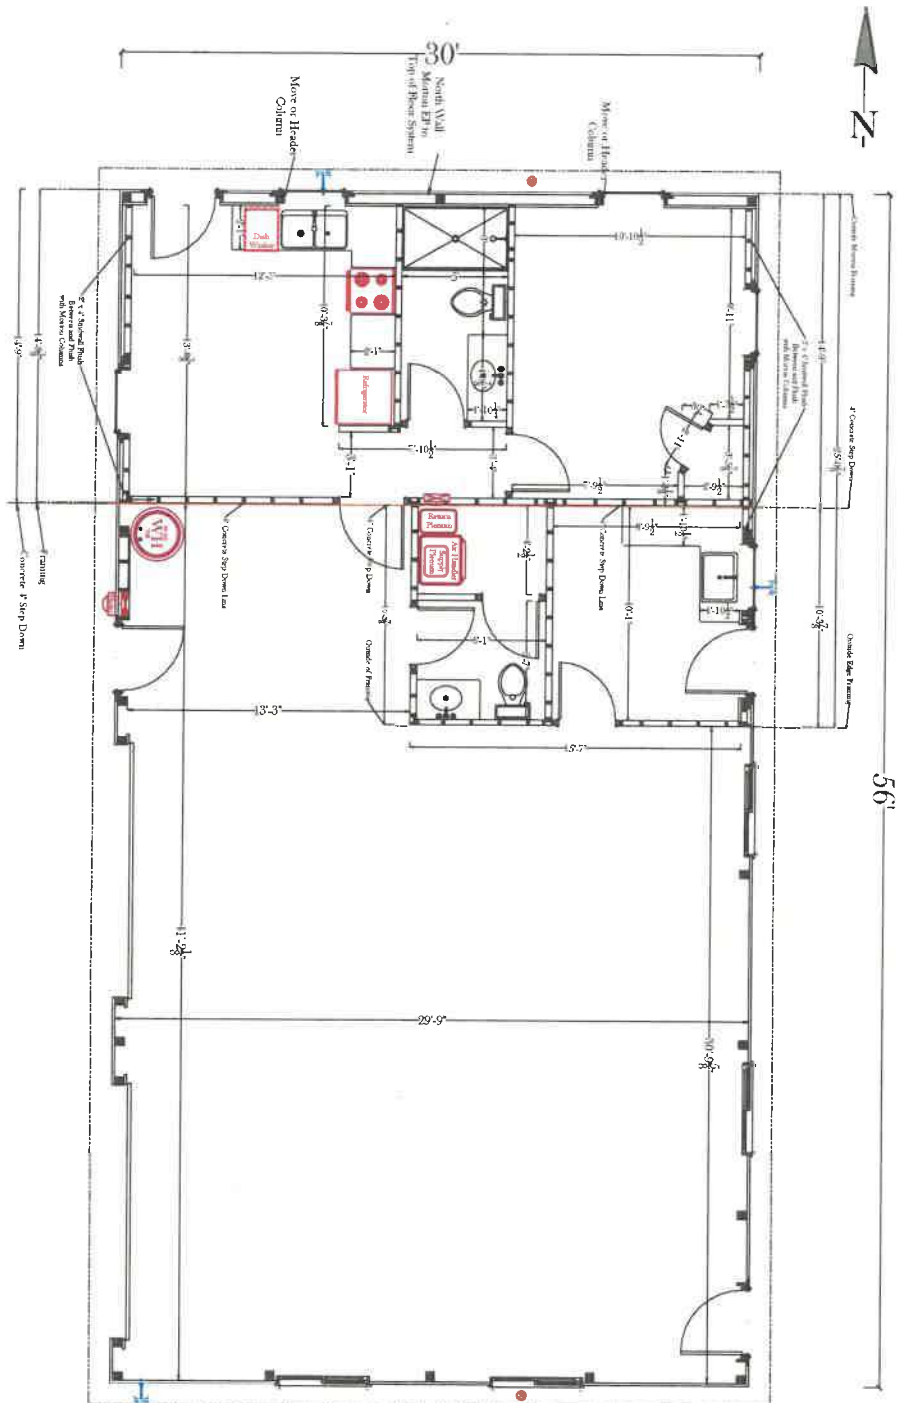

Dan Cunningham

Project Name:

Project Number:

B161

Page Description:

Framing Plan

Drawn By:

Anderson

Original Date:

7/14/25

Current Date:

8/27/25

Scale:

3/8" = 1'-0"



Page:


2 of 11



ARCHITECTURE D 06108 x 21.00 1/4" = 1'-0"

Conceptual Plans Only
Not by Licensed Professional

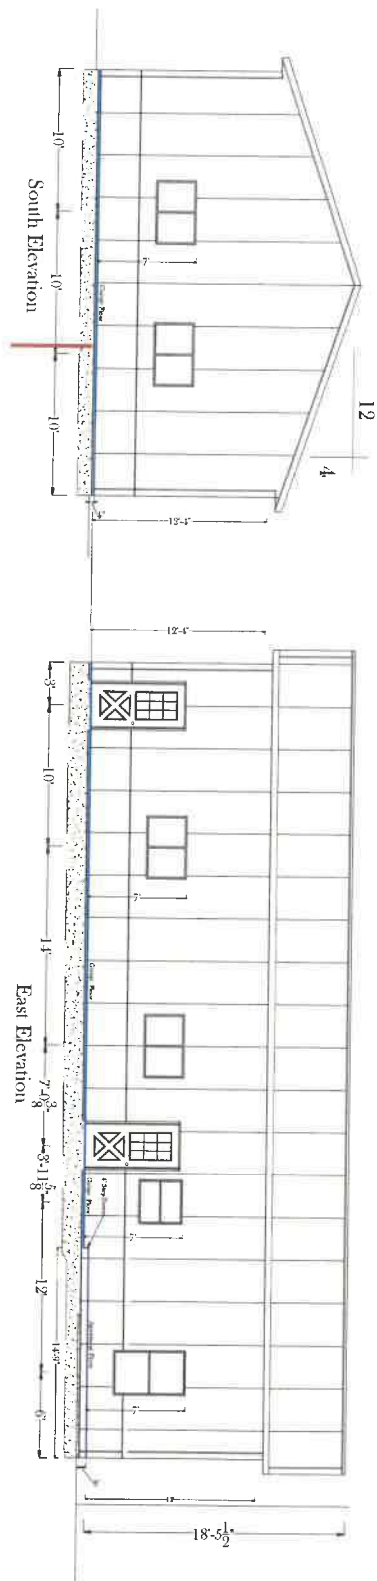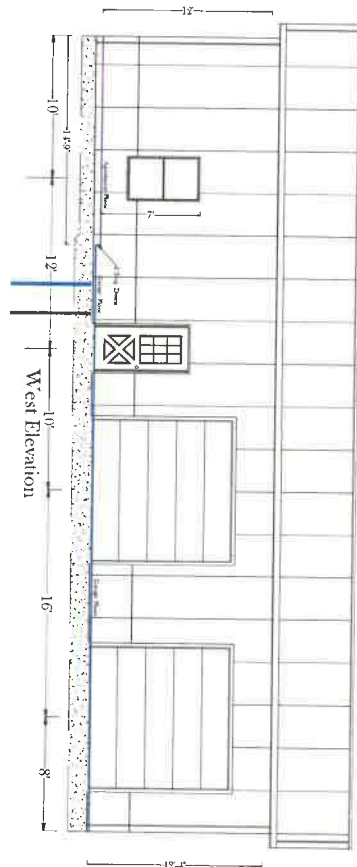


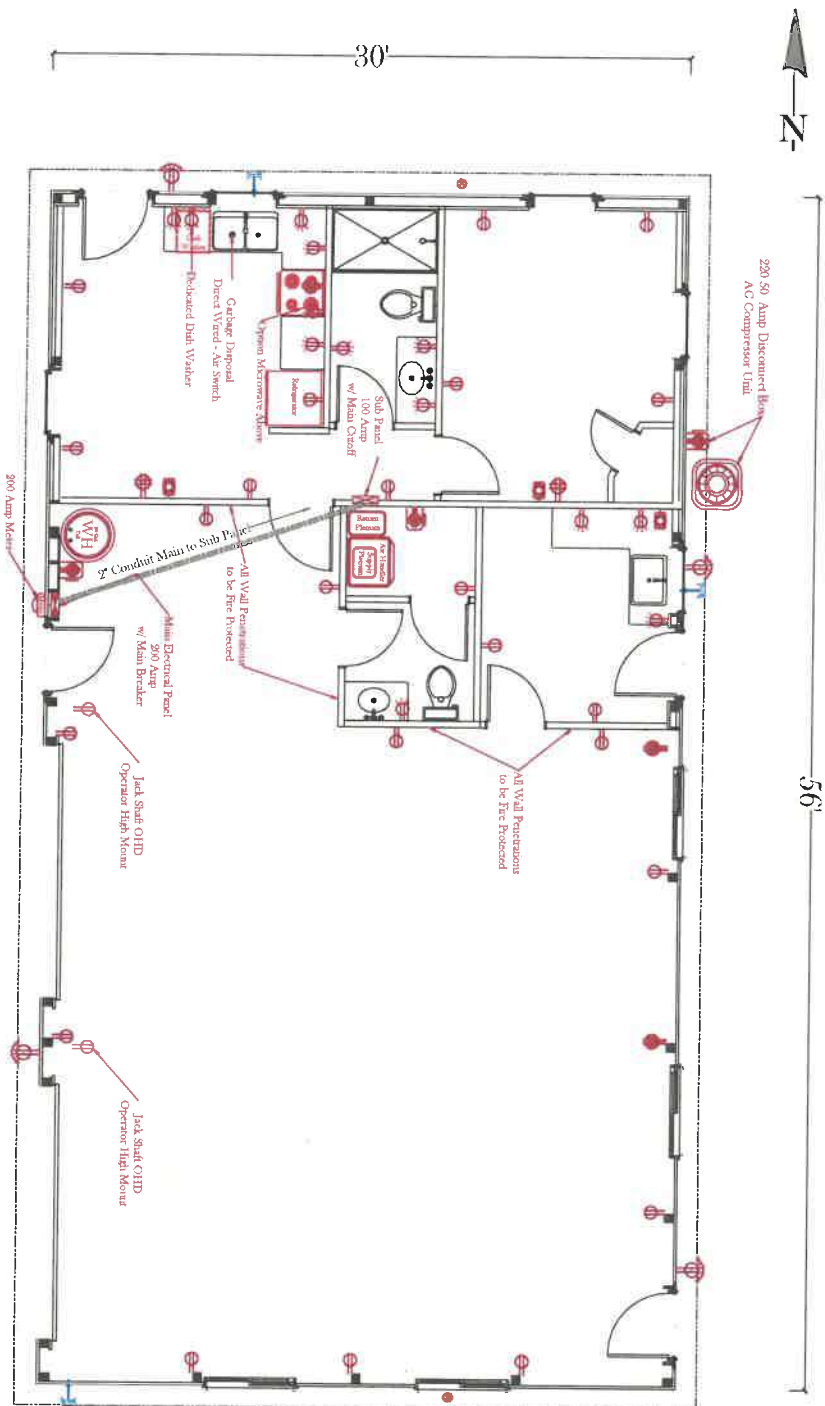

ARCH: Bill Board D: 0600 x 24.00 inches

Conceptual Plans Only
Not by Licensed Professional

Project Name: Dan Cunningham	
Project Number: B161	Page Description: Electric Walls
Drawn By: Anderson	
Original Date: 7/14/25	
Current Date: 8/27/25	
Scale: 3/8" = 1'-0"	
Page: 4 of 11	

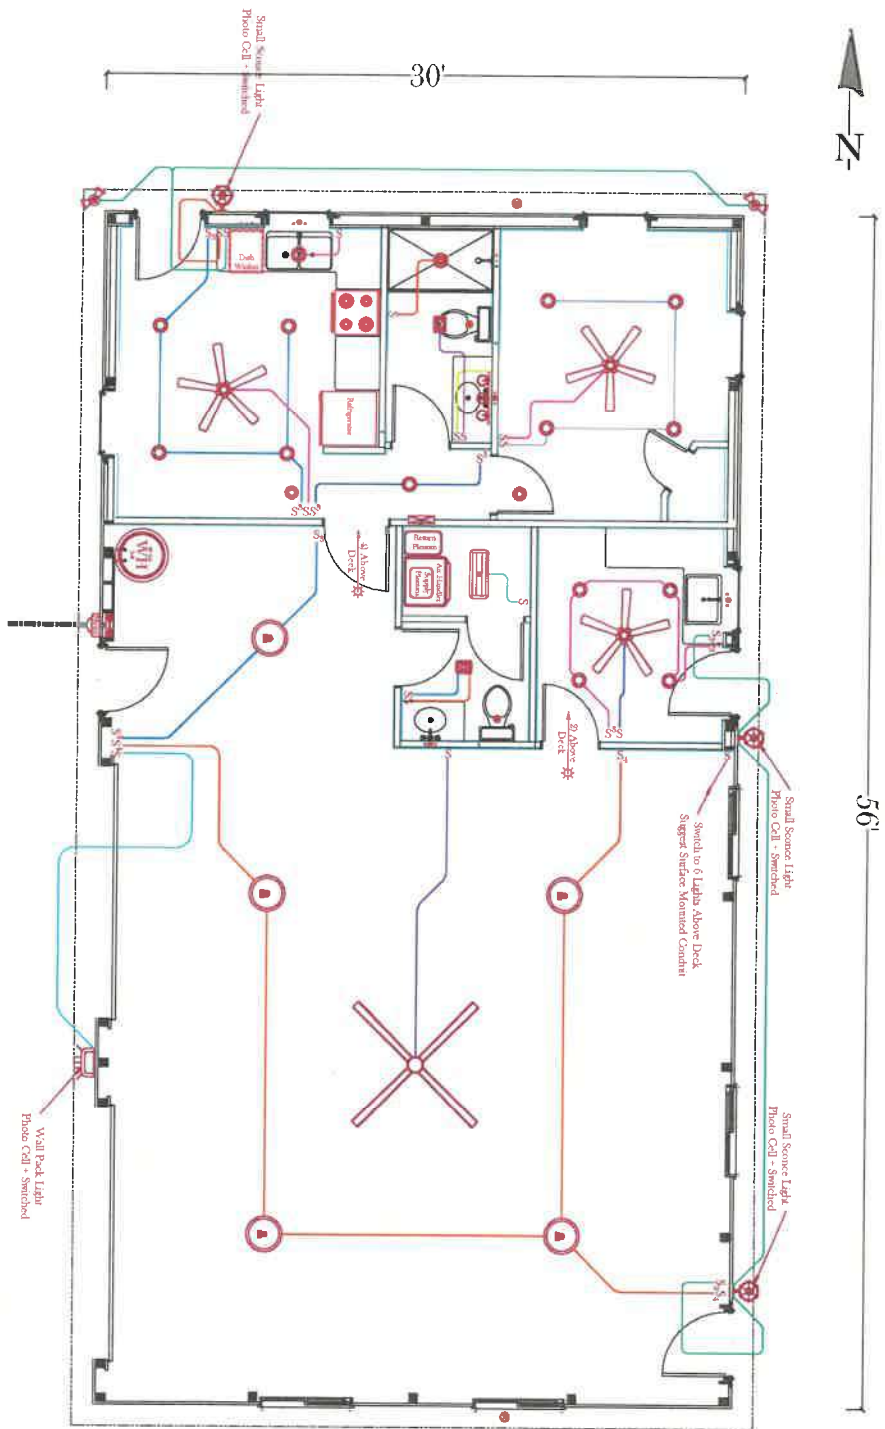

Dan Cunningham

Project Name:

Project Number:

B161

Page Description:

Electric Reflective

Drawn By:

Anderson

Original Date:

7/14/25

Current Date:

8/27/25

Scale:

3/8" = 1'-0"

Page:


5 of 11



ARCH 661 based on OCM 3.14.00 (arch)

Conceptual Plans Only
Not for Licensed Professional

Electrical Riser Schematic

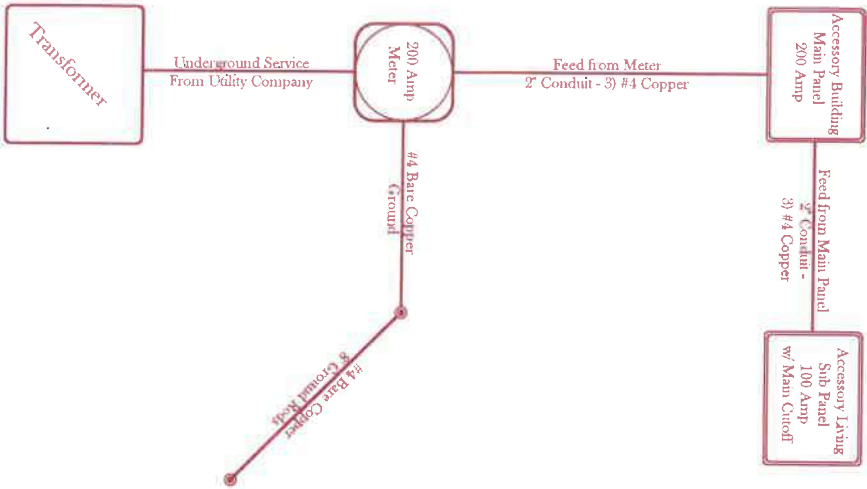

Electrical Legend		
Symbol	Description	Count
	110 Duplex Receptacle	25
	110 Duplex Receptacle - CFI	15
	110 Duplex Receptacle GFCI Weather Proof	4
	250 Receptacle 50 Amp	3
	220 Breaker 4 Pole 200Amp 4	3
	Co. As Cable Outlet	3
	Light Switch Standard Toggle	11
	Light Switch Standard Toggle 4-Pole	6
	Light 6\"/>	55
	Light 7\"/>	1
	Light 7\"/>	1
	Fan Bathroom Exhaust Fan w Light	1
	Fan Bathroom Exhaust Fan	1
	Smoke Detector	2
	Fan Ceiling 52\"/>	3
	Fan Ceiling 56\"/>	1
	GFI Light	5
	Exterior LED 2 Bulb Flood Light - Sprinkled w Fibero Optic	2
	Light Wall Pack Urban CFI	1
	Exterior Sensor Light	3
	Water Heater Conventional	1
	AC Air Handler	1
	AC Compressor	1
	100 Amp Sub Panel w Main Circuit	1
	200 Amp Panel	1
	200 Amp Meter	1

Dan Cunningham

Project Name:

Project Number:

B161

Page Description:

Electric Riser & Legend

Drawn By:

Anderson

Original Date:

7/14/25

Current Date:

8/27/25

Scale:

No Scale


Page:

6 of 11





56'

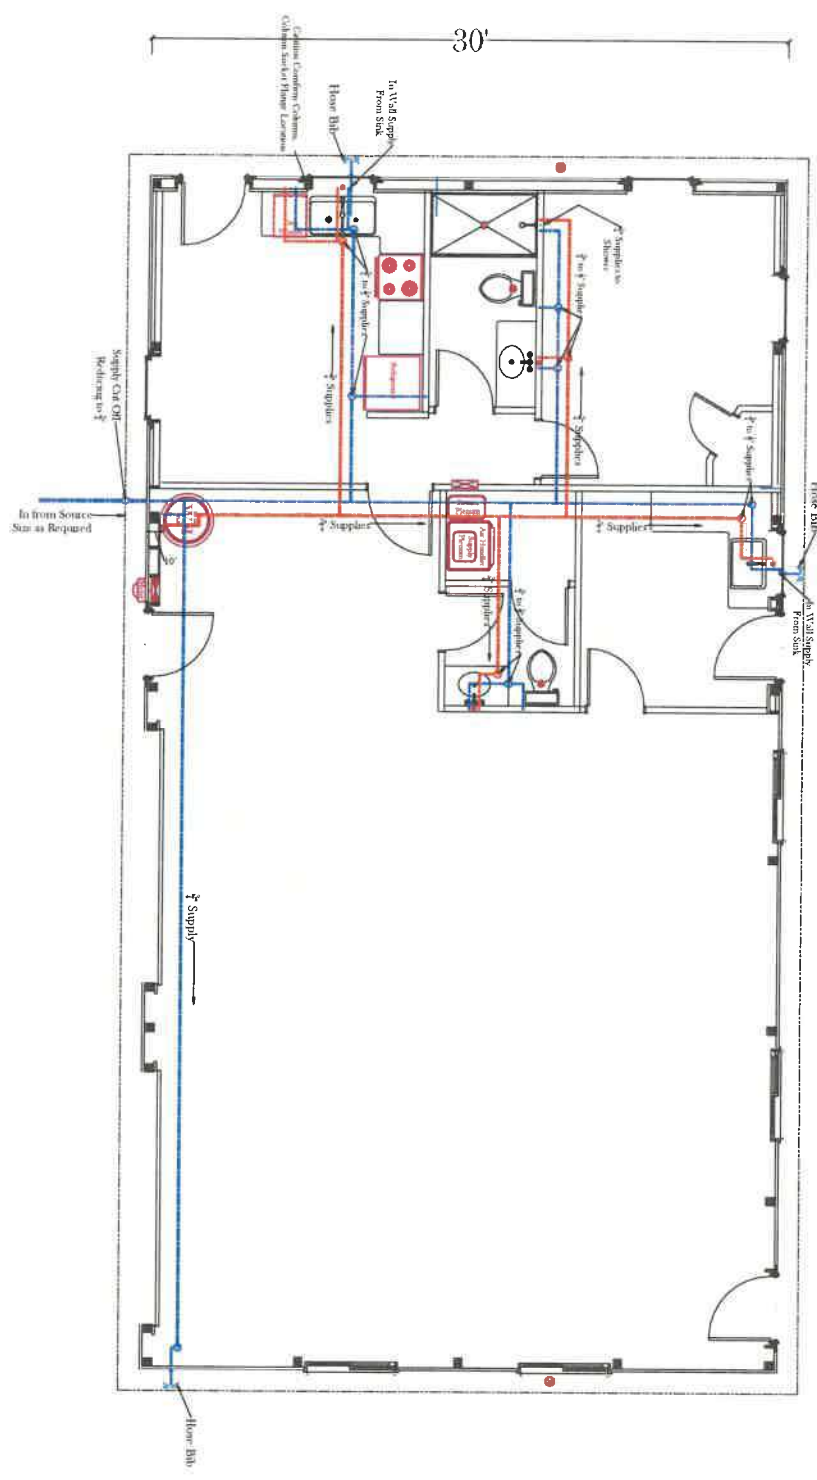


Dan Cunningham

Project Name:
Project Number:
B161

Page Description:
Plumbing Supply

Drawn By:
Anderson
Original Date:
7/14/25
Current Date:
8/27/25
Scale:
3/8" = 1'-0"
Page:
7 of 11



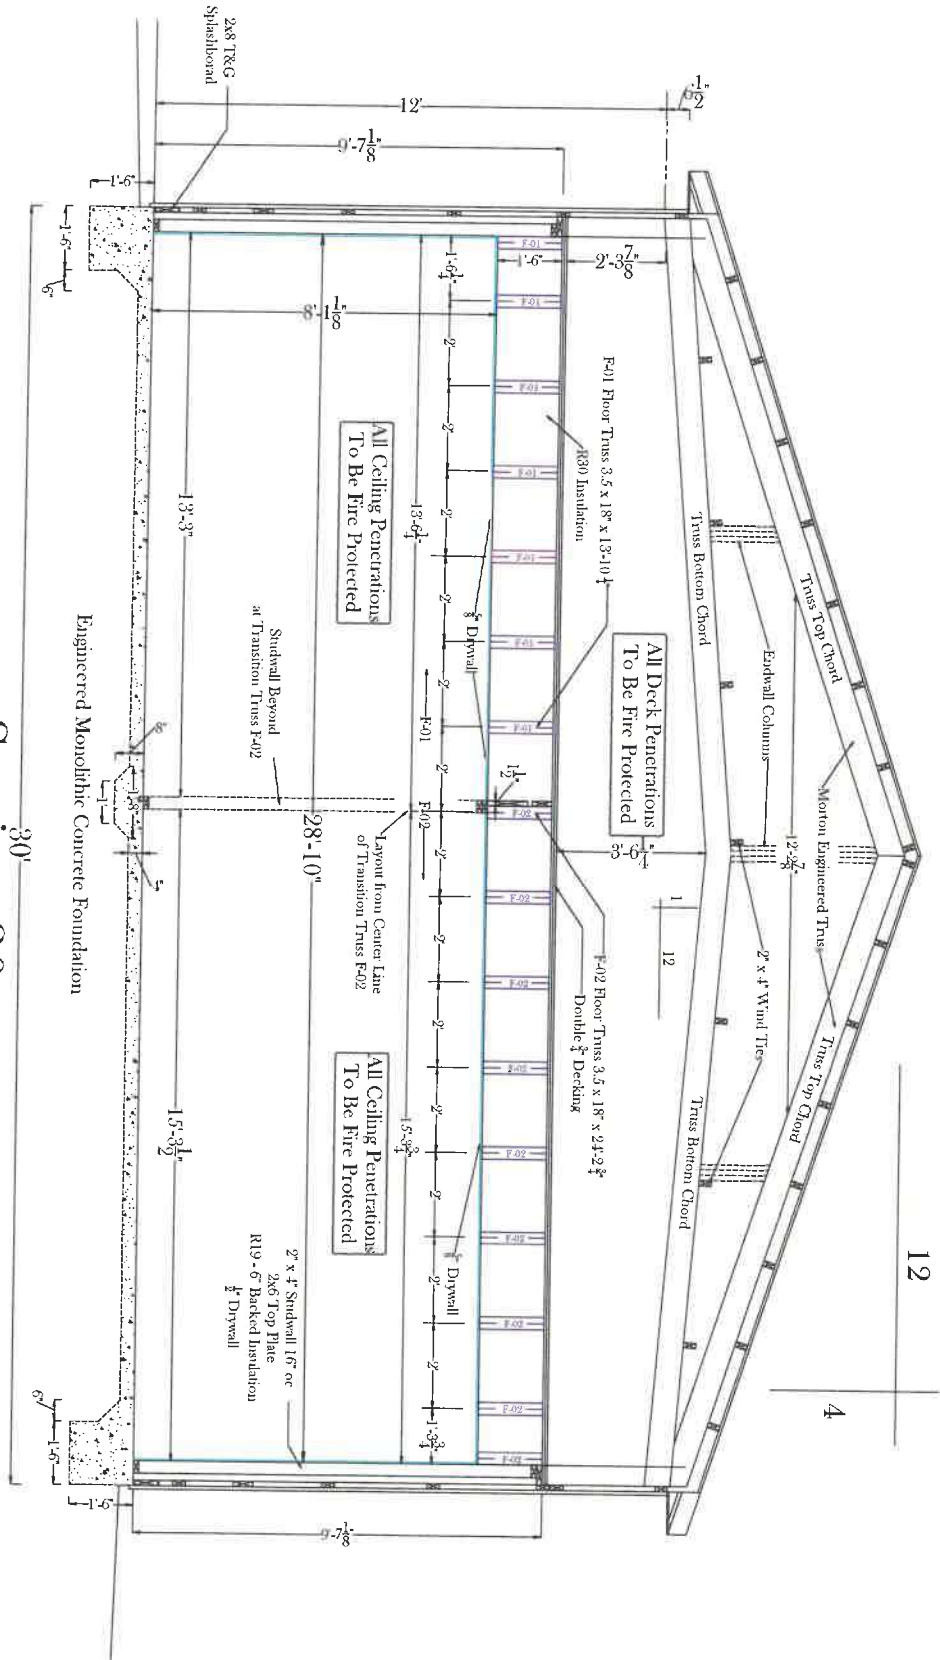

Section 30



ARCH: 08-18-12 08:00 v 21001.mxd

Project Name: Dan Cunningham		Page Description: Section 30	
Project Number: B161			
Drawn By: Anderson	Original Date: 7/14/25	Current Date: 8/27/25	Scale: 3/4" = 1'-0"
Page: 10 of 11			

