

BRIAN SMITH REMODEL

5819 Bear Lake Circle, Apopka Florida 32703



© 2023 Total Solutions Group, Inc.
Conceptual Drawing. Do Not Scale.
Refer to Construction Drawing for Specific Features



Location Map

DRAWING INDEX

SHEET NO.	SHEET TITLE
1.0	COVER SHEET
1.1	GENERAL NOTES
1.2	SITE LOCATION PLAN
1.3	FIRST FLOOR PLAN - DEMOLITION
1.4	FRONT AND LEFT ELEVATIONS - DEMOLITION
1.5	REAR AND RIGHT ELEVATIONS - DEMOLITION
1.6	ROOF PLAN - DEMOLITION
2.0	SLAB AND PAVING PLAN
2.1	FIRST FLOOR PLAN
2.2	SECOND FLOOR PLAN
3.0	FRONT AND LEFT ELEVATIONS
3.1	REAR AND RIGHT ELEVATIONS
4.0	ROOF PLAN
6.0	BUILDING SECTIONS
6.1	WALL AND STAIR SECTIONS
6.2	WATERPROOFING DETAILS
6.3	WATERPROOFING DETAILS - SIGNING
6.4	WATERPROOFING DETAILS - CWU
6.5	WATERPROOFING DETAILS - CWU
6.6	FIRST FLOOR ELECTRICAL PLAN
6.7	SECOND FLOOR ELECTRICAL PLAN
6.8	THIRD FLOOR ELECTRICAL PLAN

 
STRUCTURAL INDEX

SHEET NO.	SHEET TITLE
3.0	NOTES & SCHEDULES
3.1	FOUNDATION PLAN
3.2	LOW RISE & FLOOR FRAMING PLAN
3.3	HIGH RISE & FLOOR FRAMING PLAN
1.1	LINTEL PLAN
1.2	LINTEL, PART & NOISE
1.3	NOTES & SCHEDULES
1.4	FOUNDATION DETAILS
1.5	FRAMING DETAILS
1.6	FRAMING DETAILS
1.7	FOUNDATION DETAILS

BRIAN SMITH REMODEL

5819 Bear Lake Circle, Apopka
Florida 32703


SIGNATURE & SEAL



100% Employee Owned
TSG


TOTAL SOLUTIONS GROUP
245 Southern Lane, Suite 200
Maitland, FL 32751
(407) 888-8888
tsg.com



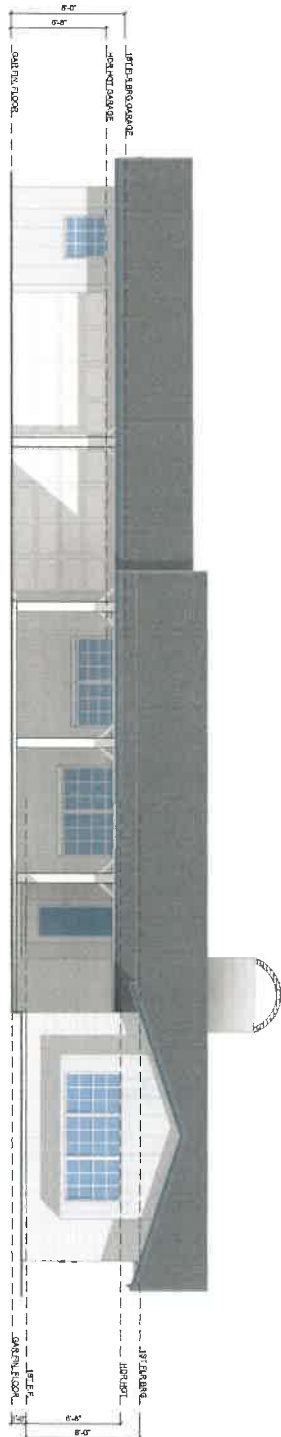

FRONT ELEVATION

SCALE: 1/4" = 1'-0"

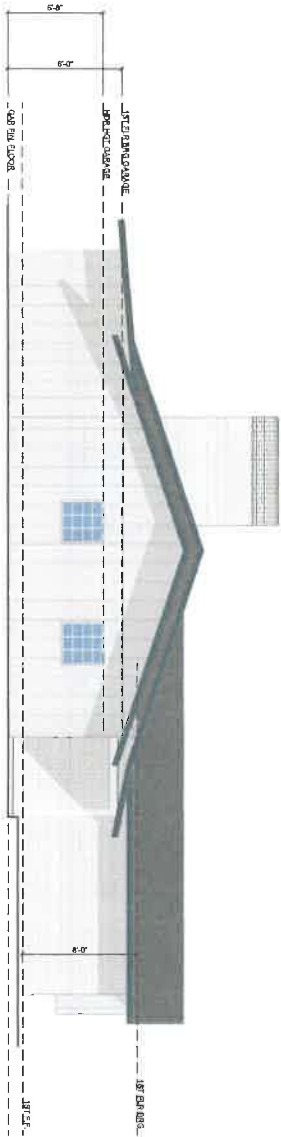

LEFT ELEVATION

SCALE: 1/4" = 1'-0"

BRIAN SMITH REMODEL

5819 Bear Lake Circle, Apopka
Florida 32703

SIGNATURE & SEAL

10/20/2019

10/20/2019

10/20/2019

10/20/2019

10/20/2019



100% Employee Owned

773.588.2233

773.588.2233

773.588.2233


773.588.2233

773.588.2233

773.588.2233


773.588.2233



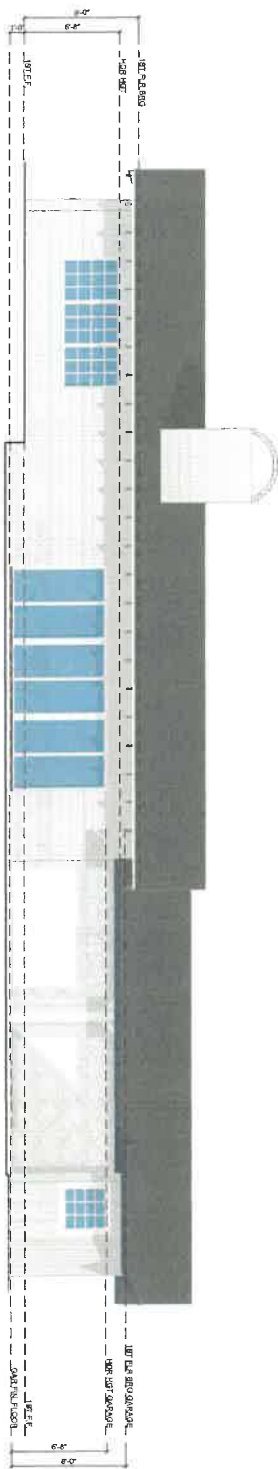

REAR ELEVATION

SCALE: 1/4" = 1'-0"

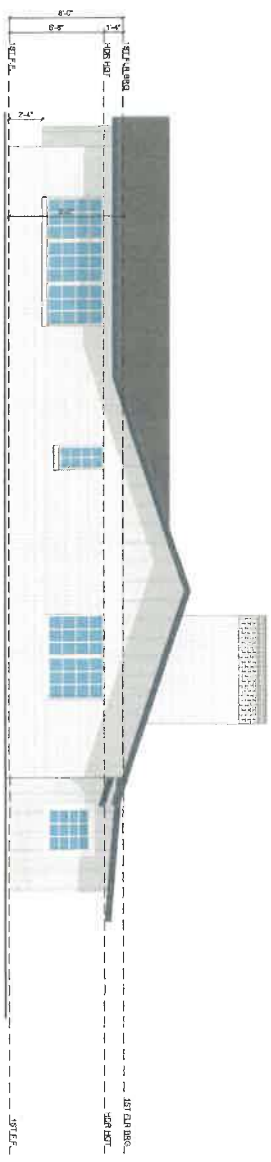

RIGHT ELEVATION

 
SCALE: 1/4" = 1'-0"

BRIAN SMITH REMODEL

5819 Bear Lake Circle, Apopka
Florida 32703

SIGNATURE & SEAL
7/10/2019


11100 N. US HWY. 17
ORLANDO, FL 32817



100% Employee Owned
TSG GROUP, INC.

TOTAL SOLUTIONS GROUP
204 South Hill Lane, Suite 200
Maitland, FL 32751
(407) 885-2222



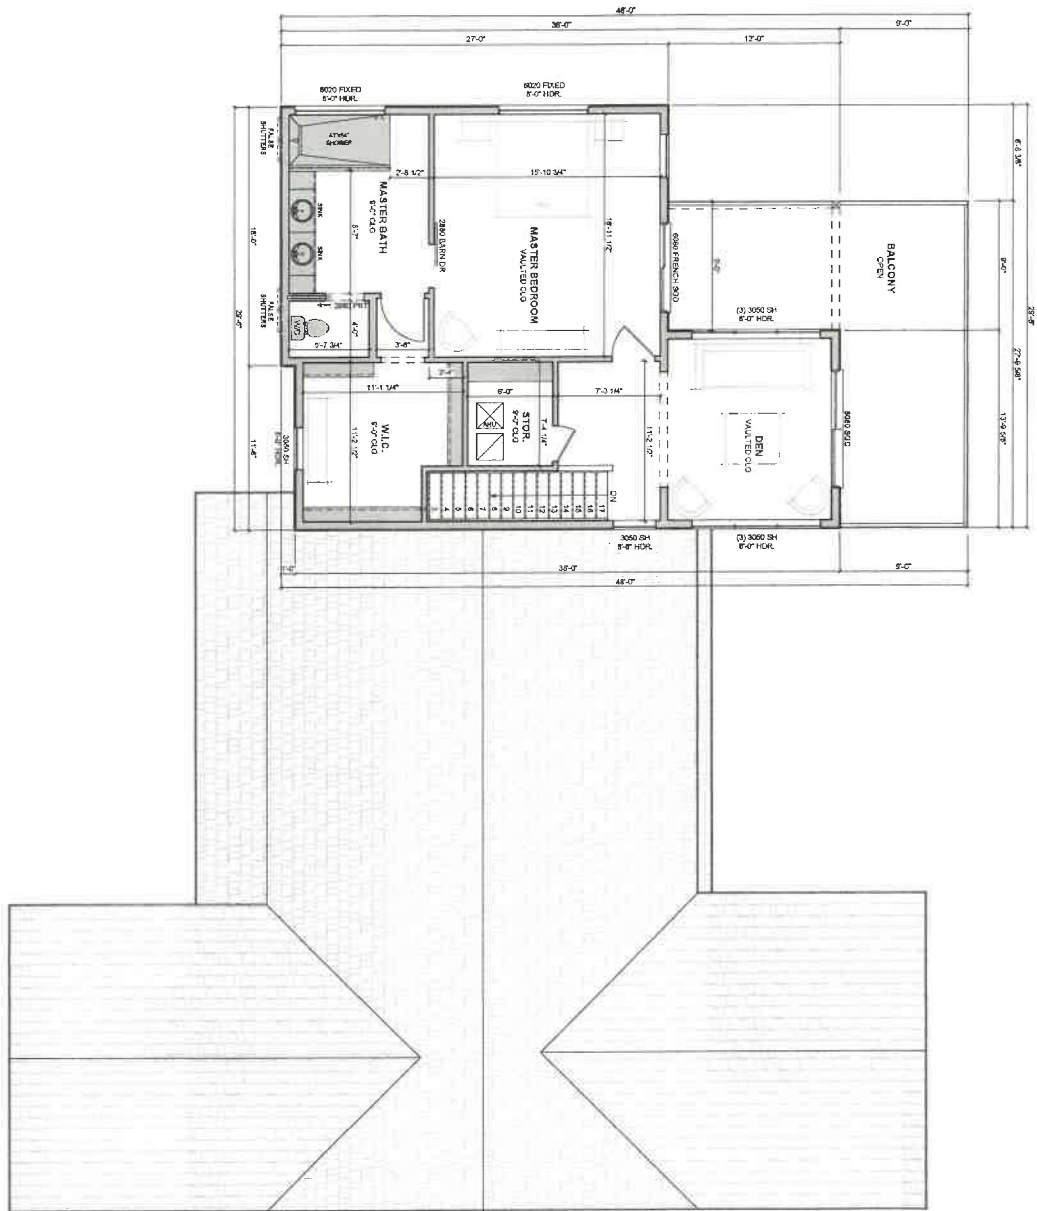

WALL LEGEND

	WALL
	WALL
	WALL
	WALL

SECOND FLOOR PLAN

SCALE

1/4" = 1'-0"

BRIAN SMITH REMODEL


5819 Bear Lake Circle, Apopka
Florida 32703

SIGNATURE & SEAL
ARCHITECT




100% Employee Owned
TOTAL SOLUTIONS GROUP
1501 S. Orange Ave., Suite 200
Orlando, FL 32801
407.860.2333
tsg@tsginc.com




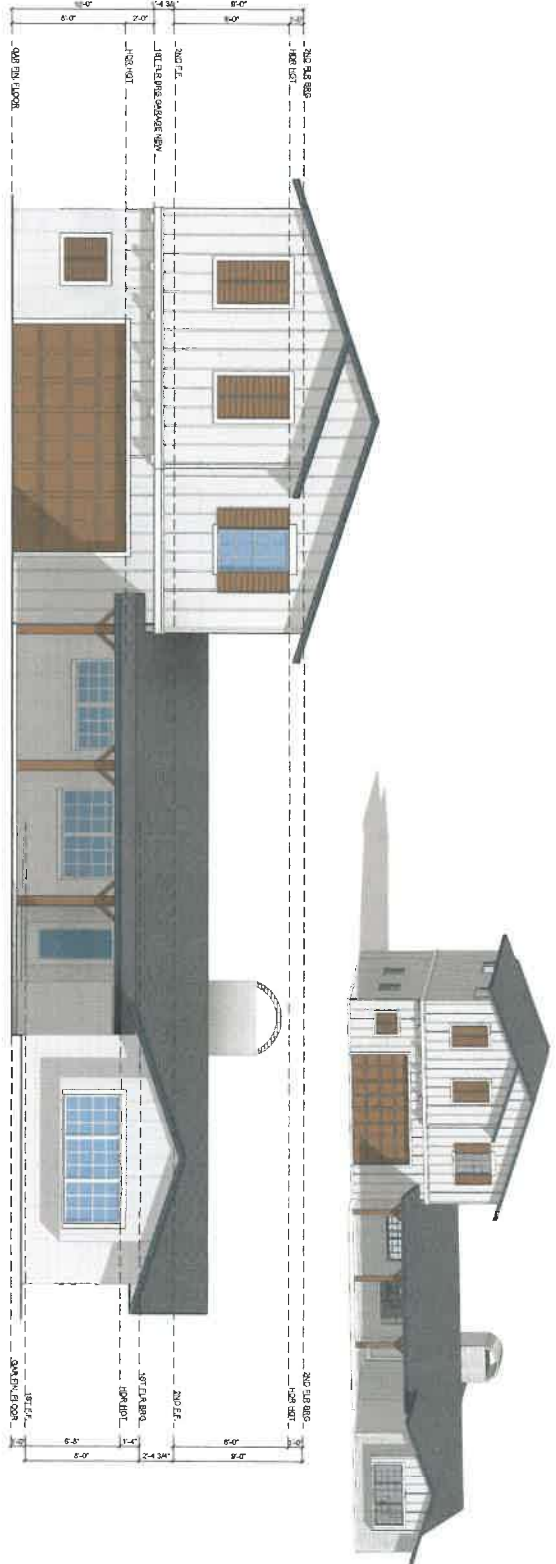

FRONT ELEVATION SCALE 1/4" = 1'-0"

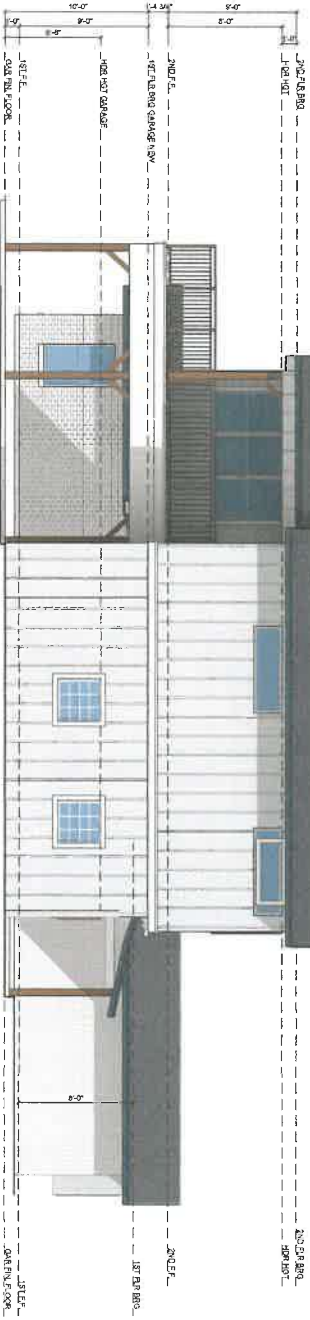

LEFT ELEVATION SCALE 1/4" = 1'-0"

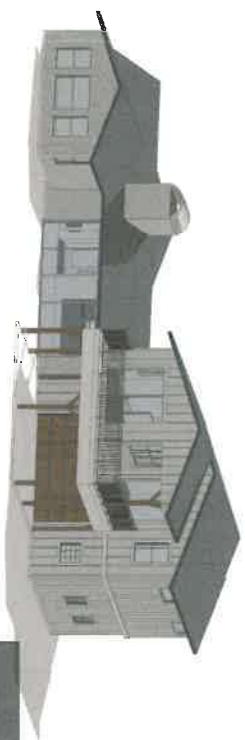


TOTAL KOLLECTIONS GROUP
2000 Main Street, Suite 100
Apopka, Florida 32703
(407) 885-2222
info@tsg.com
mytsg.com

SIGNATURE & SEAL
7/6/2023 11:23:20 AM
BRIAN SMITH, REMODEL
FLORIDA #12017

THIS IS A PRELIMINARY DRAWING. IT IS NOT TO BE USED FOR CONSTRUCTION. IT IS THE PROPERTY OF TSG AND IS NOT TO BE REPRODUCED OR TRANSMITTED IN ANY FORM OR BY ANY MEANS, ELECTRONIC OR MECHANICAL, INCLUDING PHOTOCOPYING, RECORDING, OR BY ANY INFORMATION STORAGE AND RETRIEVAL SYSTEM, WITHOUT THE WRITTEN PERMISSION OF TSG.


BRIAN SMITH REMODEL
5819 Bear Lake Circle, Apopka
Florida 32703

Project #	7-26-2023 11:23:20 AM
Client Name	7-26-2023 11:23:20 AM
Project Name	7-26-2023 11:23:20 AM
Project Address	7-26-2023 11:23:20 AM
Project Phone	7-26-2023 11:23:20 AM
Project Email	7-26-2023 11:23:20 AM
Project Website	7-26-2023 11:23:20 AM
Project Social Media	7-26-2023 11:23:20 AM
Project Notes	7-26-2023 11:23:20 AM

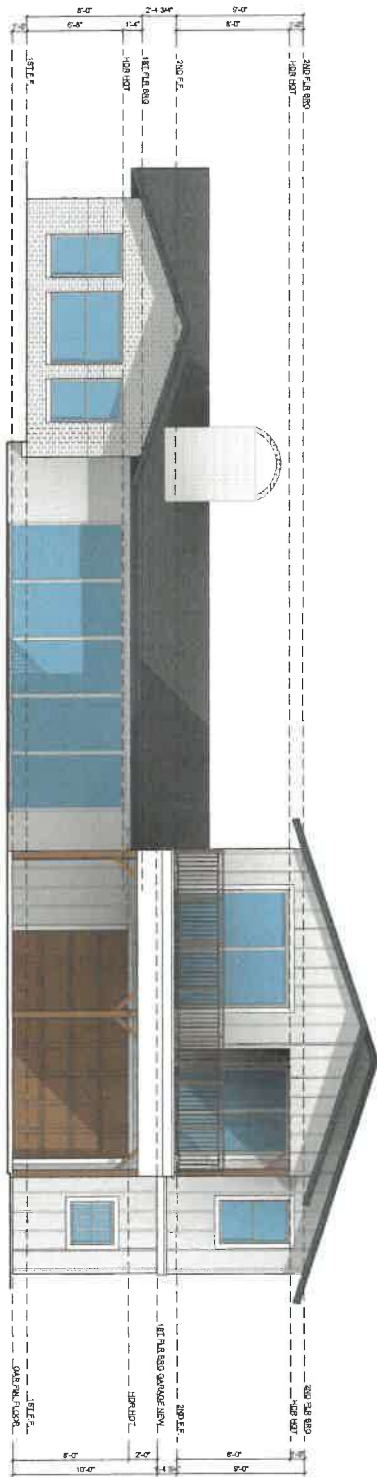

REAR ELEVATION

SCALE: 1/4" = 1'-0"

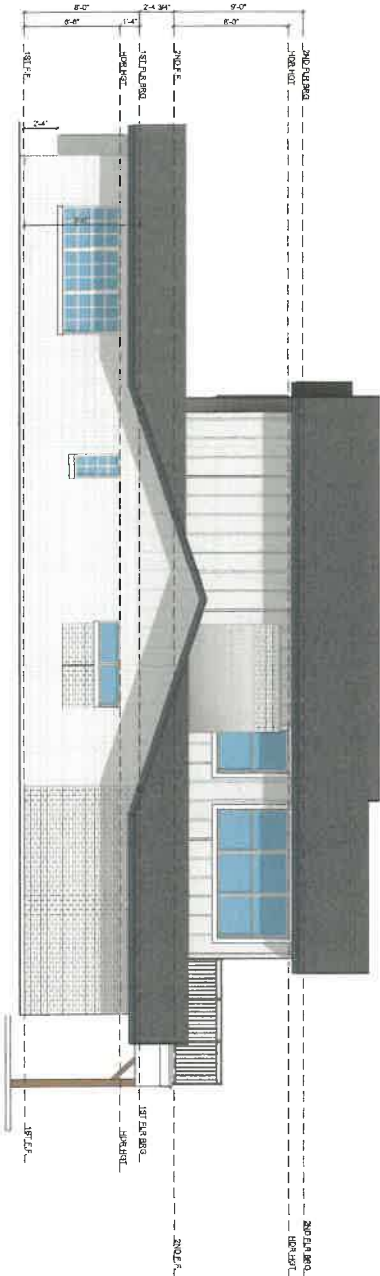

RIGHT ELEVATION

SCALE: 1/4" = 1'-0"

BRIAN SMITH REMODEL

5819 Bear Lake Circle, Apopka
Florida 32703

SIGNATURE & SEAL


Architect's Seal

10/10/2020



TOTAL SOLUTIONS GROUP
10956 Employees Owned
10956 Employees Owned
10956 Employees Owned



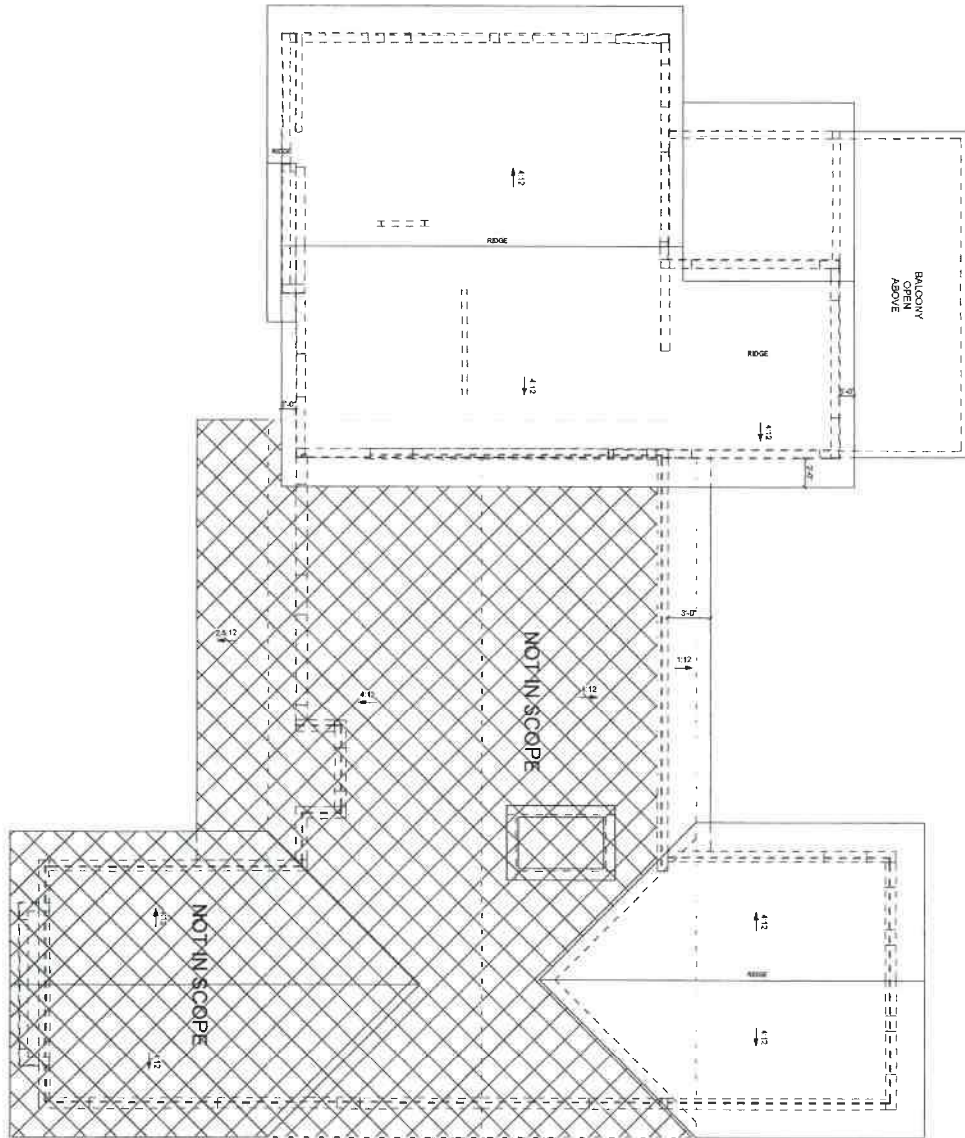

THIS PLAN IS PRELIMINARY. IT IS NOT TO BE USED FOR CONSTRUCTION. IT IS THE PROPERTY OF TSG AND IS NOT TO BE REPRODUCED OR TRANSMITTED IN ANY FORM OR BY ANY MEANS, ELECTRONIC OR MECHANICAL, INCLUDING PHOTOCOPYING, RECORDING, OR BY ANY INFORMATION STORAGE AND RETRIEVAL SYSTEM. ANY VIOLATION OF THIS NOTICE IS A VIOLATION OF THE FLORIDA BUILDING CODE.

ROOF PLAN

SCALE

1/4" = 1'-0"

BRIAN SMITH REMODEL

5819 Bear Lake Circle, Apopka
Florida 32703

SIGNATURE & SEAL
76,255 A-151-20
N/A

STAMP: TSG, INC.
LICENSE # 151-20



TSG
TOTAL SOLUTIONS GROUP
10% Employee Owned
1401 8th St.
Tomball, TX 77375
281-360-2333
tsginc.com

